



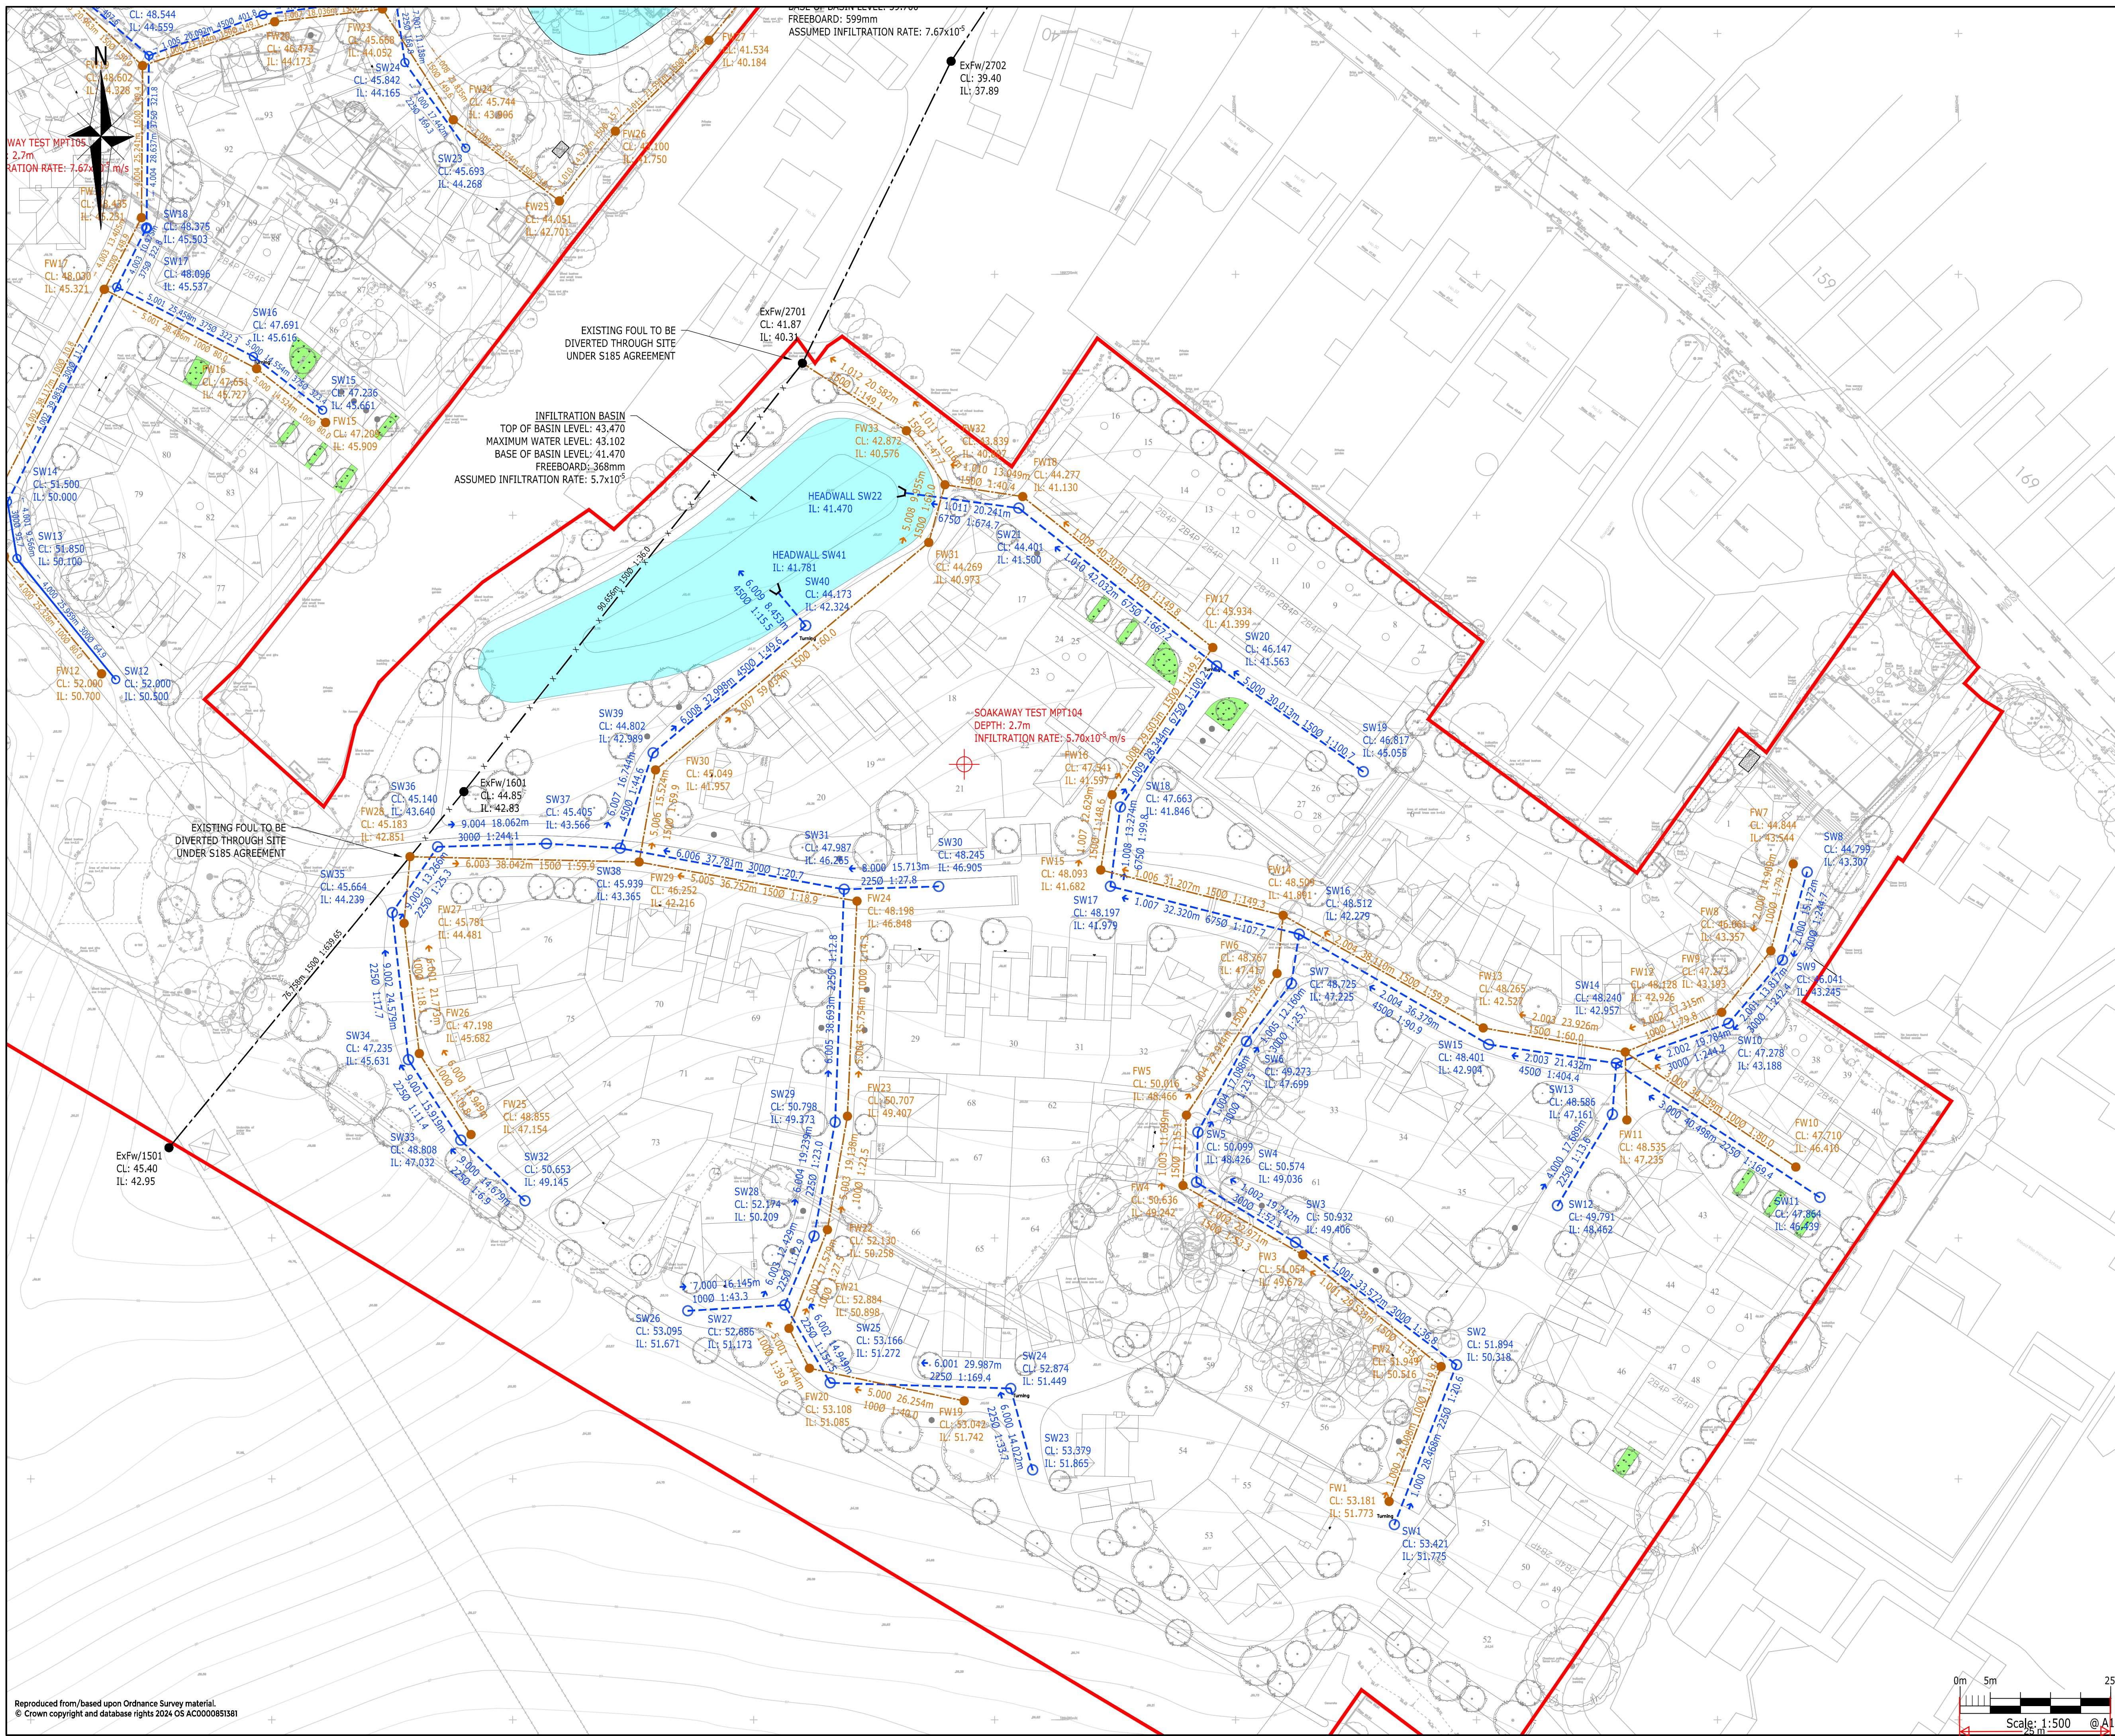

- NOTES:
- THIS DRAWING IS TO BE READ IN CONJUNCTION WITH THE RELEVANT SPECIFICATION, INC. RISK ASSESSMENTS AND ALL OTHER RELATED DRAWINGS ISSUED BY THE ENGINEER.
 - DO NOT SCALE FROM THIS DRAWING. WORK FROM FIGURED DIMENSIONS ONLY.
 - ALL DIMENSIONS SHOWN ON THIS DRAWING ARE IN METRES UNLESS OTHERWISE STATED.
 - ALL DIMENSIONS, LEVELS AND SURVEY GRID CO-ORDINATES ARE TO BE CHECKED ON SITE AND THE ENGINEER NOTIFIED IMMEDIATELY OF ANY DISCREPANCIES PRIOR TO THE COMMENCEMENT OF THE WORKS.
 - NO DEVIATION FROM THE DETAILS SHOWN ON THIS DRAWING IS PERMITTED WITHOUT PRIOR PERMISSION FROM THE ENGINEER.
 - ANY WORKS OUTSIDE RED SITE BOUNDARY ARE FOR INFORMATION PURPOSES ONLY. UNLESS SPECIFICALLY NOTED, ALL WORKS OUTSIDE THE SITE BOUNDARY WILL BE UNDERTAKEN BY OTHERS UNDER A SEPARATE CONTRACT.

DRAINAGE KEY

- EXISTING FOUL WATER SEWER & MANHOLE
- EXISTING FOUL WATER SEWER & MANHOLE TO BE GRUBBED UP
- PROPOSED FOUL WATER SEWER & MANHOLE
- PROPOSED SURFACE WATER SEWER & MANHOLE
- PROPOSED SURFACE WATER POLYSTYROM OR AGREED EQUIVALENT CRATES
- PROPOSED INFILTRATION BASIN
- POTENTIAL TREE PIT LOCATIONS

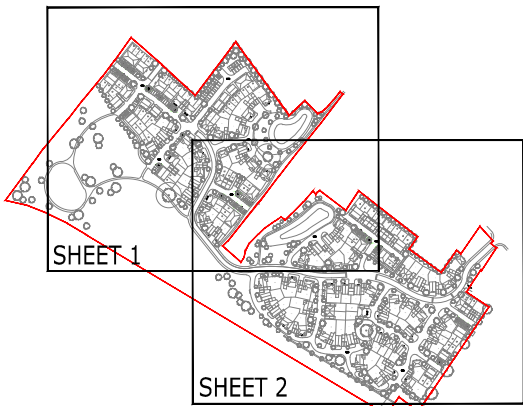

P1	FIRST ISSUE	AMC	AMC	AD	18-11-25
Rev	Description	Drn	Chk	App	Date

Purpose:	PRELIMINARY	Status:	NOT YET APPROVED
----------	-------------	---------	------------------

ARDENT CONSULTING ENGINEERS
AN EMPLOYEE OWNED COMPANY

Third Floor
The Hallmark Building
52-56 Leadenhall Street
London
EC3M 5JE

Tel: 020 7680 4088
Web: www.ardent-ce.co.uk
E-mail: enquiries@ardent-ce.co.uk

SSIP
SAFETY
BUREAU VERITAS

Client: **ESQUIRE DEVELOPMENTS**

Project Title: **ROSE FARM, ISTEAD RISE**

Drawing Title: **PROPOSED DRAINAGE LAYOUT SHEET 2**

Drawn by AMC	Checked by AMC	Approved by AD	Revision P1
Scale 1:500@A1	Date 18-11-25		
Drawing Number 2500920-ACE-XX-XX-DR-C-0702			

